



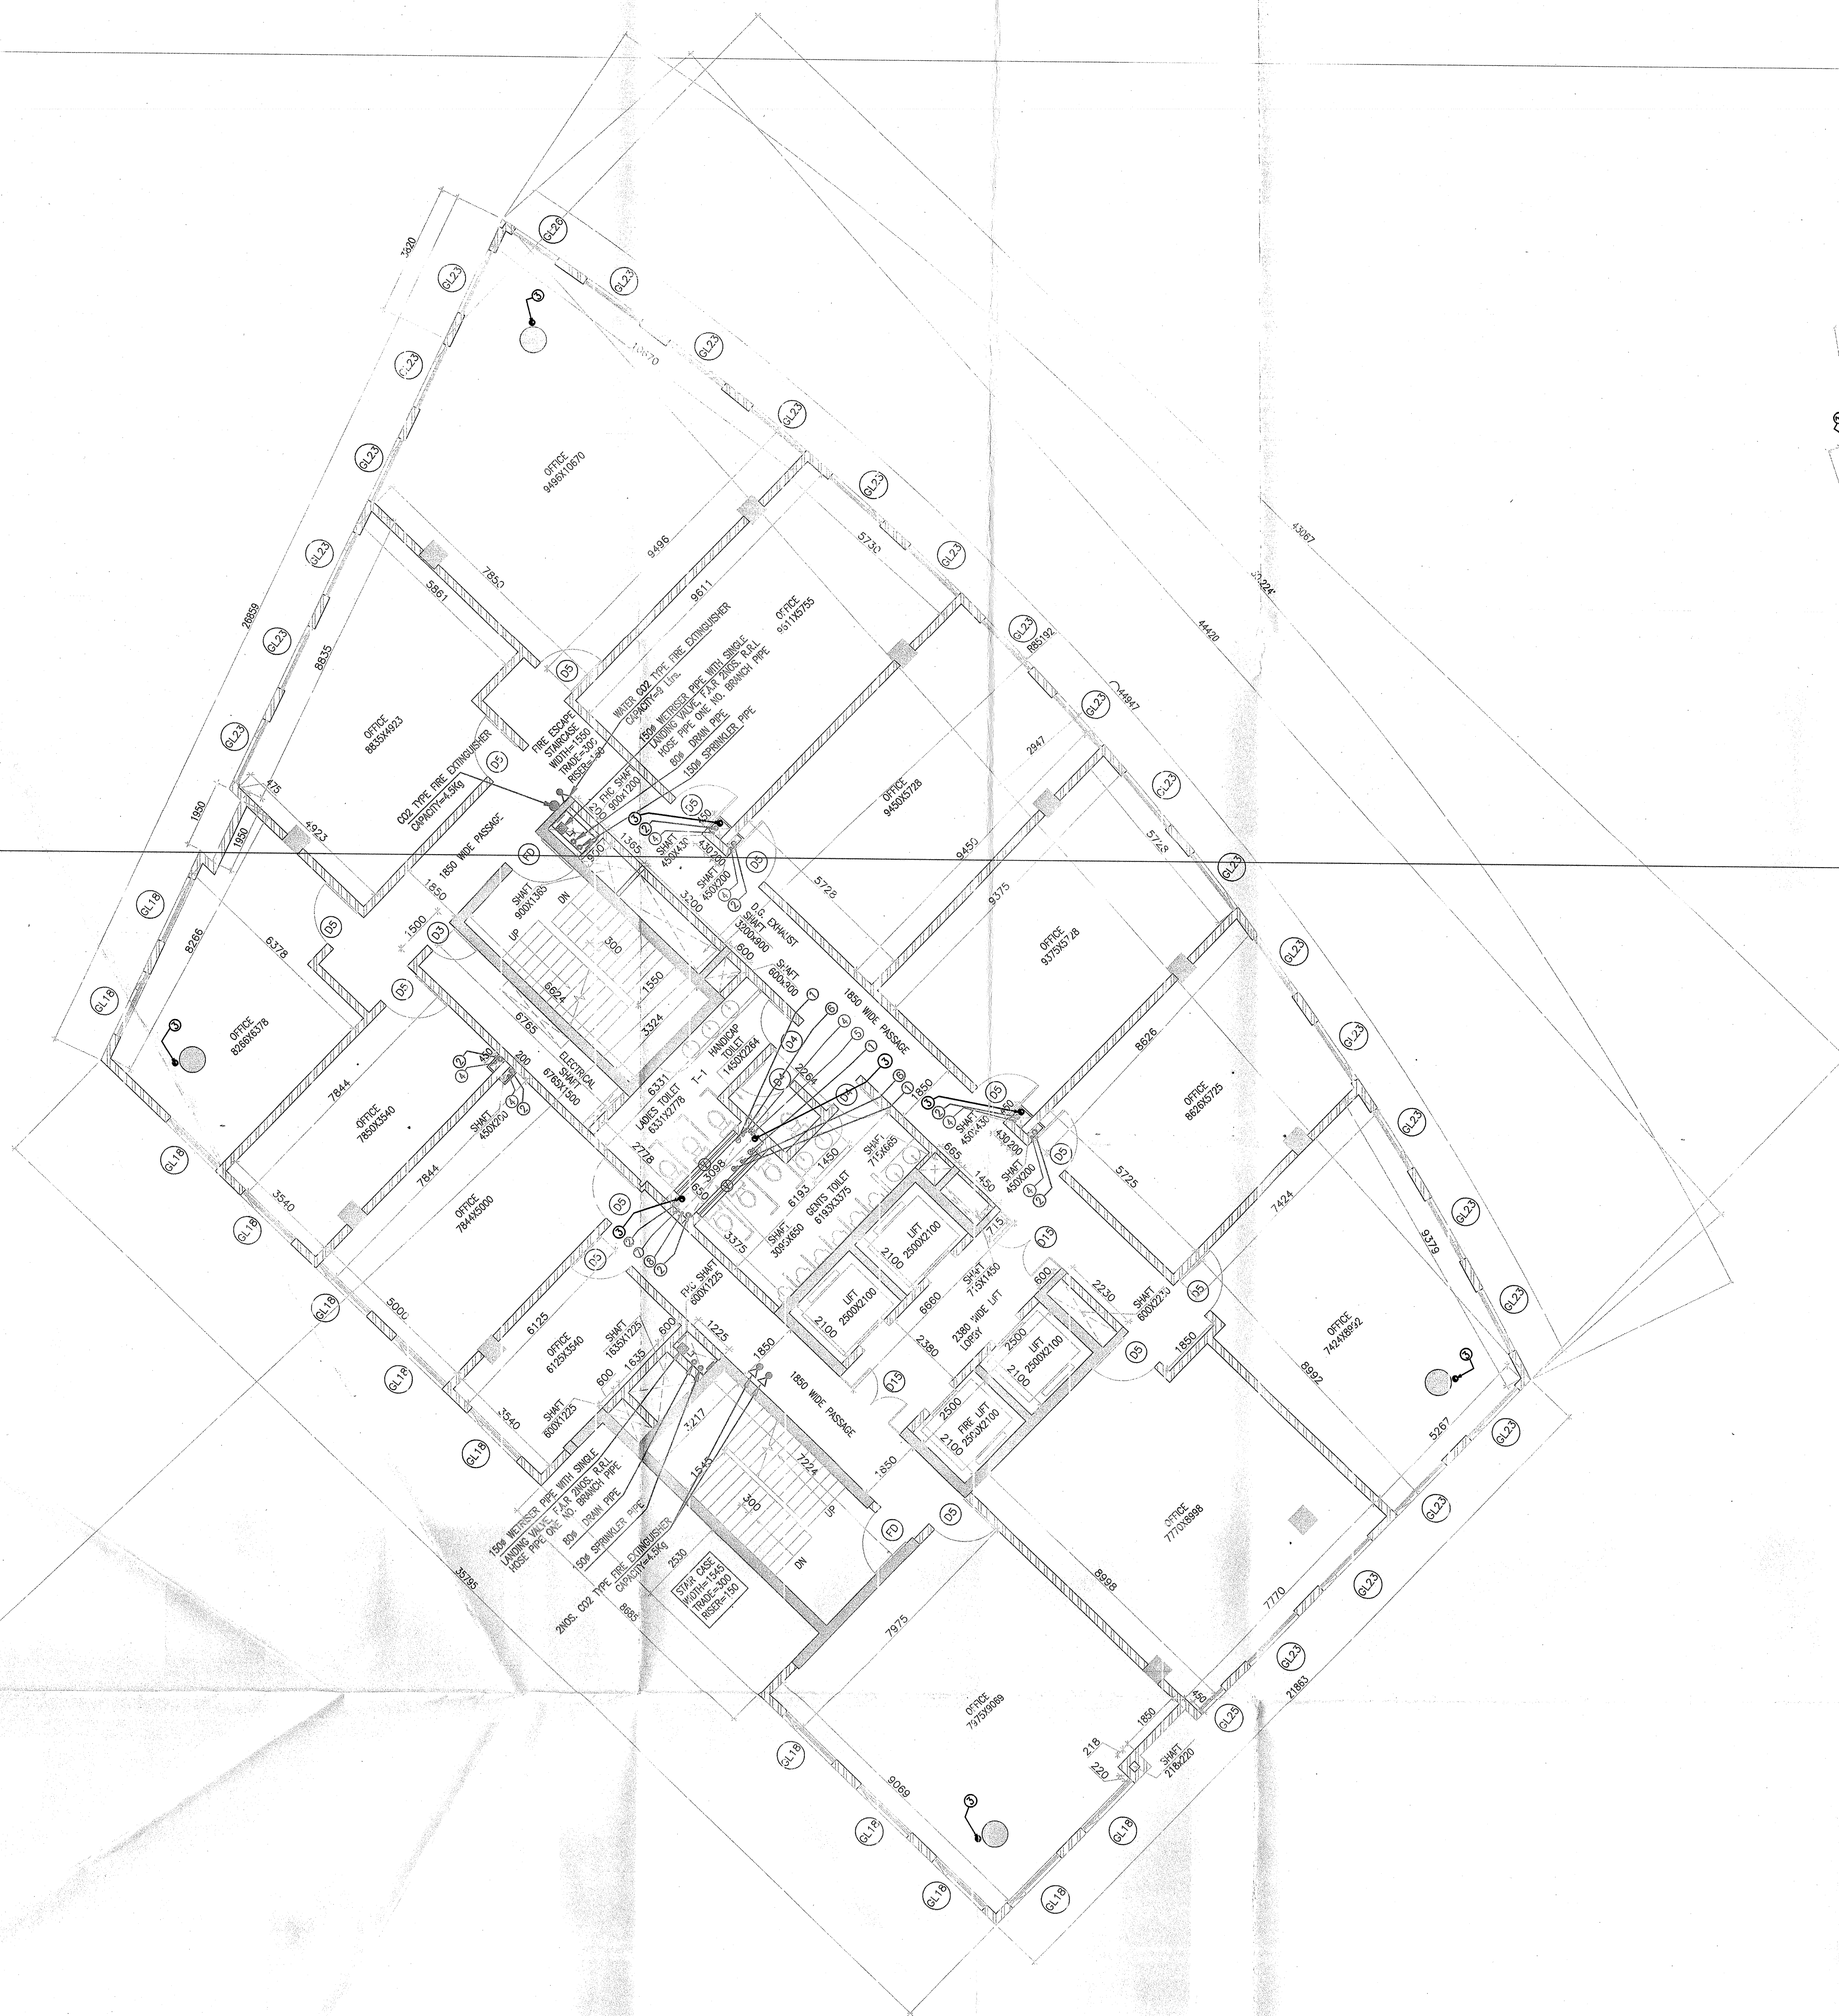

(BLOCK-D)
12th FLOOR PLAN
LEVEL +45250

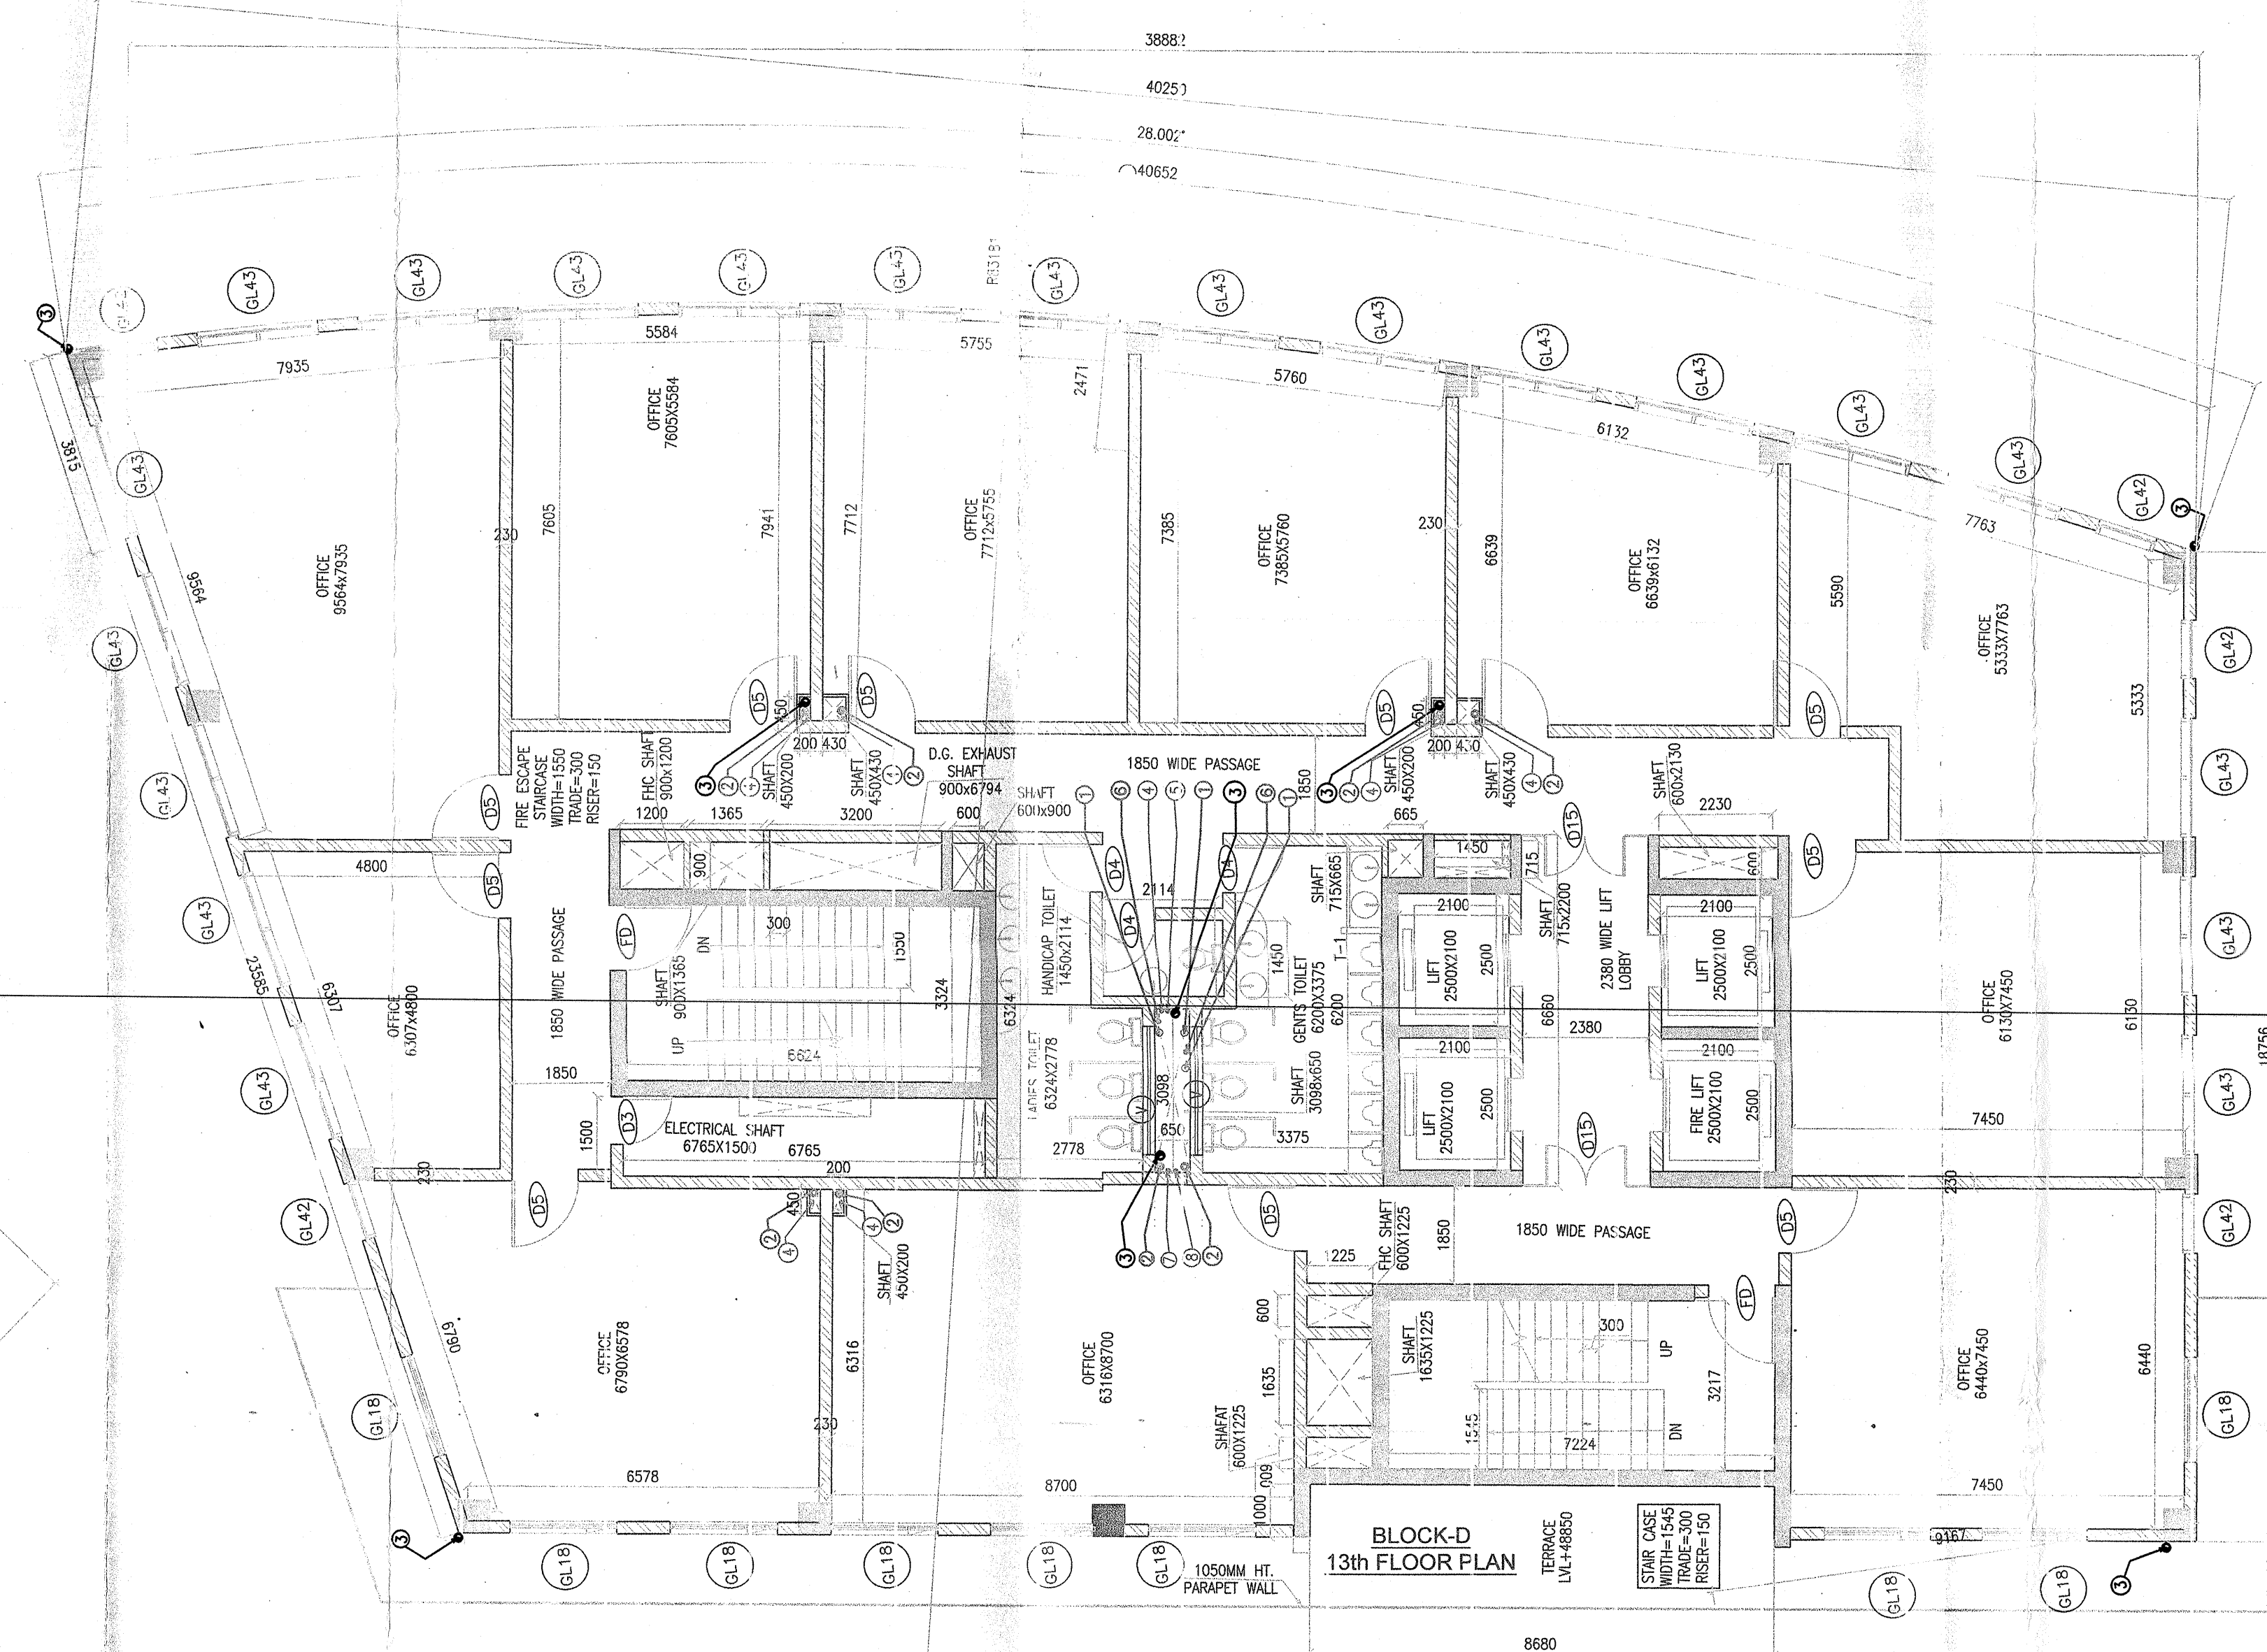

Note:-

1. BUILDING WILL BE DESIGNED (STRUCTURES) AS PER RELEVANT IS CODES FOR EARTH QUAKE RESISTANCE.
2. THE BUILDING COMPLY WITH FIRE NORMS

LEGEND:-

LEGEND :-

SYM.	DESCRIPTION
①	100# SOIL & VENT PIPE
②	100# WASTE & VENT PIPE
③	150# RAIN WATER PIPE
④	100# RAIN WATER PIPE
⑤	80x6.5x4.6# DOMESTIC WATER SUPPLY
⑥	80x6.5x4.6# FLUSHING WATER SUPPLY
⑦	75# ANTI-SIPHONAGE PIPE
⑧	50# DOMESTIC WATER TANK FILLING
⑨	40# DOMESTIC WATER TANK FILLING
⑩	KHURRA 450X450

Project:-

PROPOSED COMMERCIAL COLONY AREA MEASURING 2.961 ACRES. (LICENCE NO. 110 OF 2010 DATED 29-12-2010) IN SECTOR-82-A, GURGAON MANESAR URBAN COMPLEX BEING DEVELOPED BY SH. TEJPAL S/O SH. BADAM SINGH AND SMT. SAKUNTALA DEVI W/O SH. TEJPAL IN COLLABORATION WITH M/S VATIKA LTD.

Associate Architects

RSMS ARCHITECTS

RSMS ARCHITECTS PVT. LTD.
69,Nora Niwas Bhawani Kunj
(Behind D2), Vasant Kunj,
New Delhi-110070.
Tel.: 011-26898613, 26898617
www.rsms-arch.com


D.P.O. (Municipal Engineer)
S.P.O. (Municipal Engineer)
C.T.P. (Municipal Engineer)

AD ID PA ATP

Checked and found ok for Public Health
Internal Circulation only subject to comments in
forwarding letter No. S/100/2010, D. 5.5.1.1

ARCHITECT'S SEAL & SIGNATURE

OWNER'S SEAL & SIGNATURE

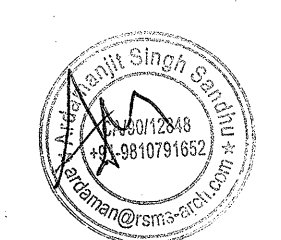

For Vatik Limited
Authorized Signatory

JULY-2011

Scale : 1:100

Drawing Title:-
12TH & 13TH
FLOOR PLAN
(BLOCK-D)

Drawing No:-
D-04